

REVISIONS:

STERK ENGINEERING, INC.
 P.O. Box 575, Calistoga, CA 94515 • (707) 942-2245
 Consulting Civil Engineers • FAX (707) 942-2215
 email: djsterk@att.net


PREPARED FOR:
LOGGY TEEN CENTER & ART CENTER BUILDING
 1401 NORTH OAK ST., CALISTOGA, CA 94515
SITE GRADING & DRAINAGE PLAN
 APN 011-140-056



CHECKED BY: DJ STERK
 DRAWN BY: DJ STERK
 DATE: 6 NOV 2009
 JOB #: 07-049
 FILE: 4002.DWG

C2.0

DRAINAGE PIPING LAYOUT PLAN
SCALE: 1"=10'

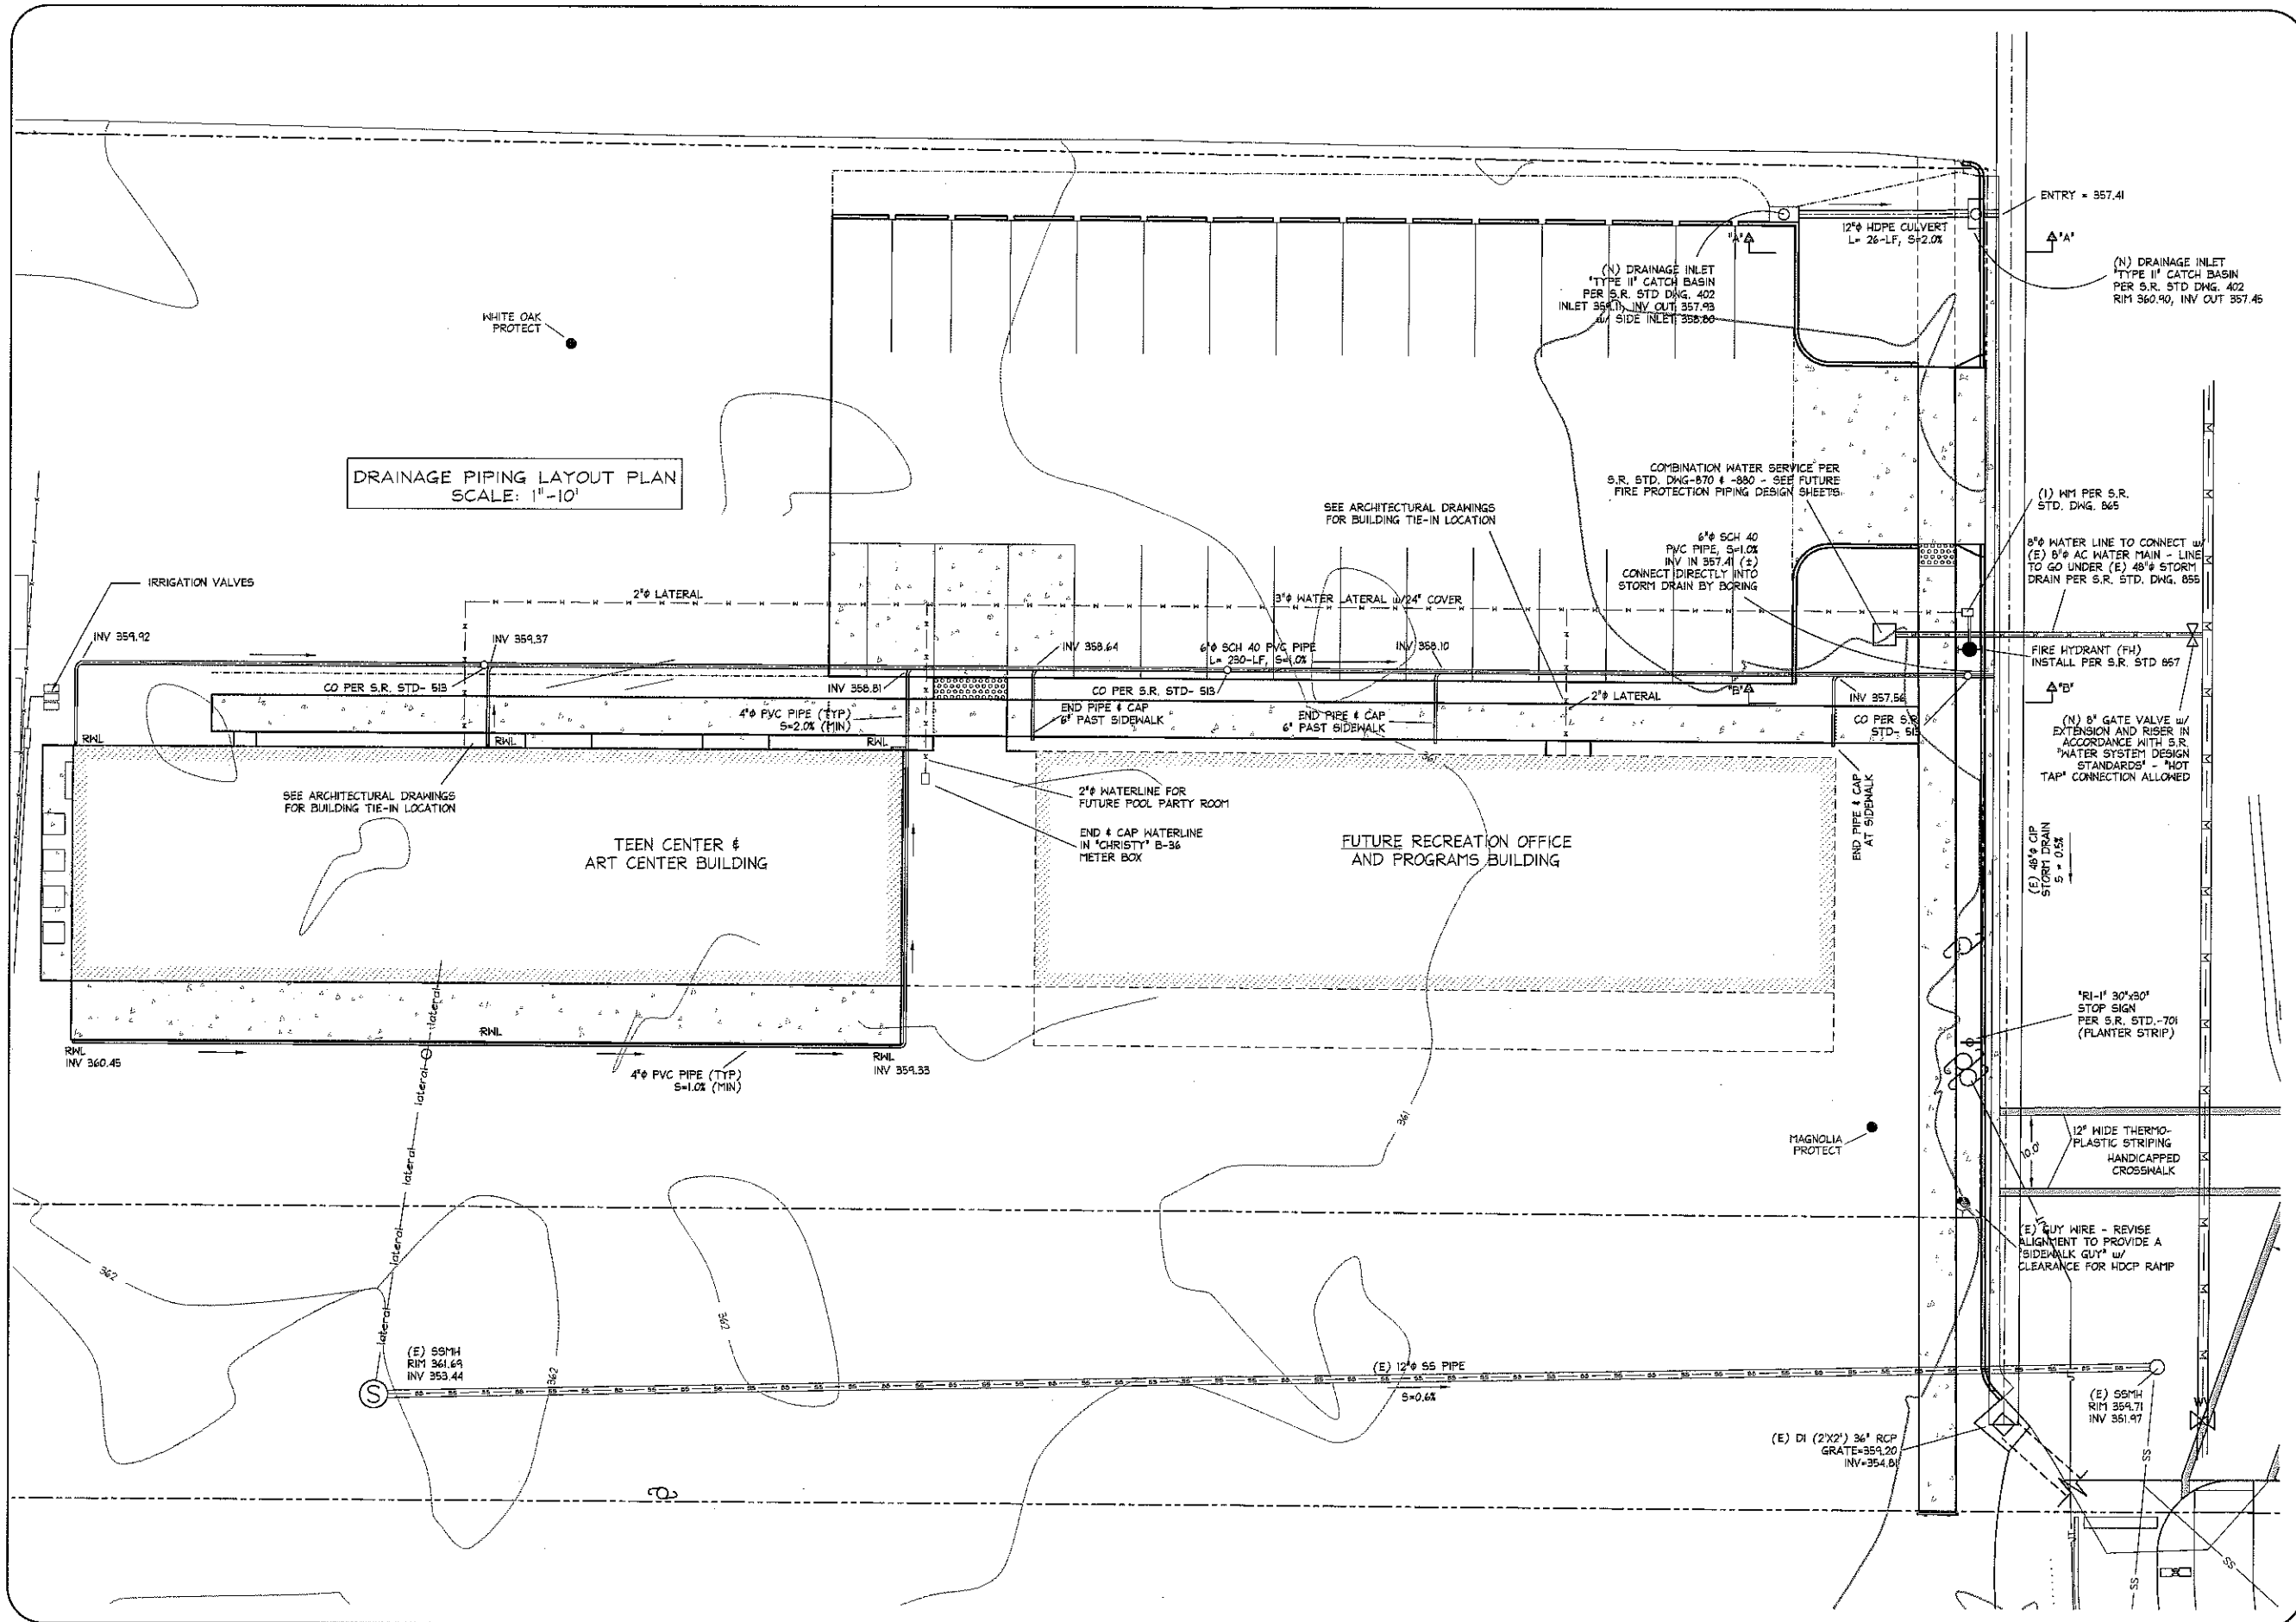

REVISIONS:

STERK ENGINEERING, INC.
 P.O. Box 575, Calistoga, CA 94515 • (707) 942-2245
 Consulting Civil Engineers • FAX (707) 942-2215
 email: dsterk@att.net

PREPARED FOR:
LOGGY TEEN CENTER & ART CENTER BUILDING
 1401 NORTH OAK ST., CALISTOGA, CA 94515
DRAINAGE PIPING LAYOUT PLAN
 APN 011-140-056



CHECKED BY: DJ STERK
 DRAWN BY: DJ STERK
 DATE: 6 NOV 2009
 JOB #: 07-049
 FILE: 4003.DWG

C3.0